



MIDDLE EAST INTELLIGENT
BUILDING
CONSULTANT'S Co.
**INTELLIGENT SOLUTION
PROVIDER**

Tel: +98 (21) 22721537
Fax: +98 (21) 22721538
www.mibc.ir

PROJECT NAME
SAMPLE BUILDING

EMPLOYER
MIBC

DRAWING TITLE
CONTROL DIAGRAM PRIVATE AREA

DRAWING NO


ISSUED FOR COMMENT AFC AS-BUILT


 
 
 
DESIGNED:

DRAWN:






CHECKED:

 

 


 


APPROVED:

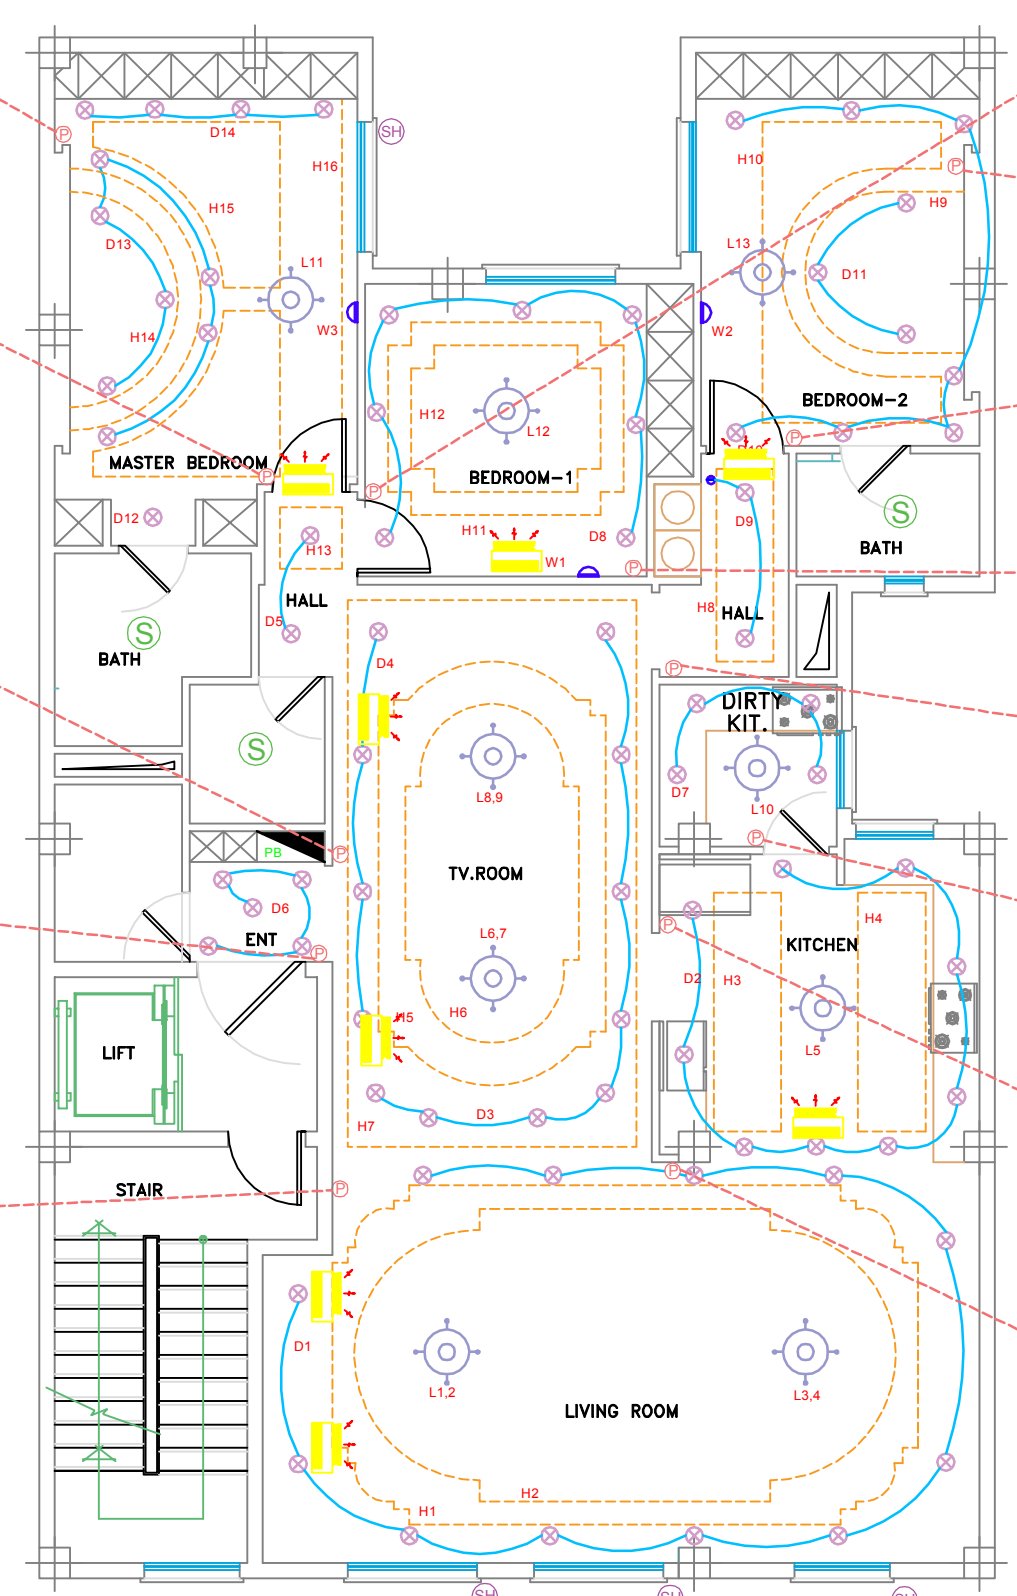
NORTH POINT  SIZE: **A3**
SCALE: **NO-SCALE**

کلید 5/10 ترموستات تریاتون	
کلید 3/6 ترموستات تریاتون	
کلید 3/6 نرمال تریاتون	
مبدل هوشمند دو کاناله	

S	Shade
D	Decorative
L	Luster
W	Wall Light
H	Hidden
P	Push Button
T	Thermostat

- P5₁ Short Push H15
Long Push Exit Mode
 - P5₂ Short Push H14
Long Push D14
- 
-
- P4₁ Enter Mode
 - P4₂ Exit Mode
 - P4₃ L11
 - P4₄ L11
 - P4₅ D13
 - P4₆ D14
 - P4₇ H15
 - P4₈ H16
 - P4₉ Shutter
 - P4₁₀ Shutter
- 
-
- P3₁ L8
 - P3₂ L9
 - P3₃ L6
 - P3₄ L7
 - P3₅ D5
 - P3₆ H13
 - P3₇ D4
 - P3₈ D3
 - P3₉ H5
 - P3₁₀ H6
- 
-
- P2₁ Enter Mode
 - P2₂ Exit Mode
 - P2₃ D6
 - P2₄ D6
 - P2₅ H5
 - P2₆ H6
- 
-
- P1₁ Enter Mode
 - P1₂ Exit mode
 - P1₃ L1
 - P1₄ L2
 - P1₅ L3
 - P1₆ L4
 - P1₇ D1
 - P1₈ D2
 - P1₉ Shutter 1
 - P1₁₀ Shutter 2
- 

- P6₁ Exit Mode
 - P6₂ Enter Mode
 - P6₃ L12
 - P6₄ D8
 - P6₅ H11
 - P6₆ H12
- 
-
- P7₁ Short Push W2
Long Push Exit Mode
 - P7₂ Short Push D11
Long Push H9
- 
-
- P8₁ Exit Mode
 - P8₂ Enter Mode
 - P8₃ L13
 - P8₄ D10
 - P8₅ H9
 - P8₆ H10
- 
-
- P9₁ Short Push W1
Long Push Exit Mode
 - P9₂ Short Push H12
Long Push H11
- 
-
- P10₁ Short Push D9
Long Push Exit Mode
 - P10₂ H8
- 
-
- P11₁ Exit Mode
 - P11₂ Enter Mode
 - P11₃ L10
 - P11₄ D7
 - P11₅ Hidden
 - P11₆ Kitchen
- 
-
- P12₁ Exit Mode
 - P12₂ Enter Mode
 - P12₃ L5
 - P12₄ D2
 - P12₅ H3
 - P12₆ H4
- 
-
- P13₁ Exit Mode
 - P13₂ Enter Mode
 - P13₃ L3
 - P13₄ L4
 - P13₅ H3,H4
 - P13₆ H1,H2
- 



FLOOR PLAN

ABB-ADVANCE