



MIDDLE EAST INTELLIGENT
BUILDING
CONSULTANT'S Co.
**INTELLIGENT SOLUTION
PROVIDER**

Tel: +98 (21) 22721537
Fax: +98 (21) 22721538
www.mibc.ir

PROJECT NAME
SAMPLE BUILDING

EMPLOYER
MIBC

DRAWING TITLE
CONTROL DIAGRAM PRIVATE AREA

DRAWING NO

ISSUED FOR COMMENT AFC AS-BUILT

DESIGNED:

DRAWN:

CHECKED:

APPROVED:

NORTH POINT



SIZE:
A3

SCALE:
NO-SCALE

کلید پیرریان کامل با صفحه 3 اینچ



کلید 3/6 ترموستات پیرریان



کلید 3/6 نورمال پیرریان

 


مبدل هوشمند دو کاناله




S	Shade
D	Decorative
L	Luster
W	Wall Light
H	Hidden
P	Push Button
T	Thermostat


- P5₁ Short Push H15
Long Push Exit Mode
- P5₂ Short Push H14
Long Push D14



 
- P4₁ Enter/Exit Mode
- P4₂ L11
- P4₃ D13
- P4₄ D14
- P4₅ D15
- P4₆ Shutter



 - P3₁ Enter/Exit Mode
- P3₂ L8,L9
- P3₃ L6,L7
- P3₄ D5
- P3₅ D4
- P3₆ H13



 - P2₁ Enter Mode
- P2₂ Exit Mode
- P2₃ D6
- P2₄ D6
- P2₅ H5
- P2₆ H6




- P1₁ Enter Mode
- P1₂ Exit Mode
- P1₃ L1,L2
- P1₄ L3,L4
- P1₅ D1,D2
- P1₆ H1,H2



- Page 1
Control Living room
- Page 2
Control Kitchen
- Page 3
Control Dining room
- Page 4
Control Bedroom 2
- Page 5
Control Bedroom 3
- Page 6
Control Nook
- Page 7
Control fan coils
- Page 8
Control Shutter



 - P6₁ Exit Mode
- P6₂ Enter Mode
- P6₃ L12
- P6₄ D8
- P6₅ H11
- P6₆ Shutter



- P7₁ Short Push W2
Long Push Exit Mode
- P7₂ Short Push D11
Long Push H9



- P8₁ Exit Mode
- P8₂ Enter Mode
- P8₃ L13
- P8₄ D10
- P8₅ H9
- P8₆ H10



 
- P9₁ Short Push W1
Long Push Exit Mode
- P9₂ Short Push H12
Long Push H11




- P10₁ Short Push D9
Long Push Exit Mode
- P10₂ H8




- P11₁ Exit Mode
- P11₂ Enter Mode
- P11₃ L10
- P11₄ D7
- P11₅ Shutter
- P11₆ Shutter



 - P12₁ Exit Mode
- P12₂ Enter Mode
- P12₃ L5
- P12₄ D2
- P12₅ H3
- P12₆ H4



- P13₁ Exit Mode
- P13₂ Enter Mode
- P13₃ L3
- P13₄ L4
- P13₅ H3,H4
- P13₆ H1,H2

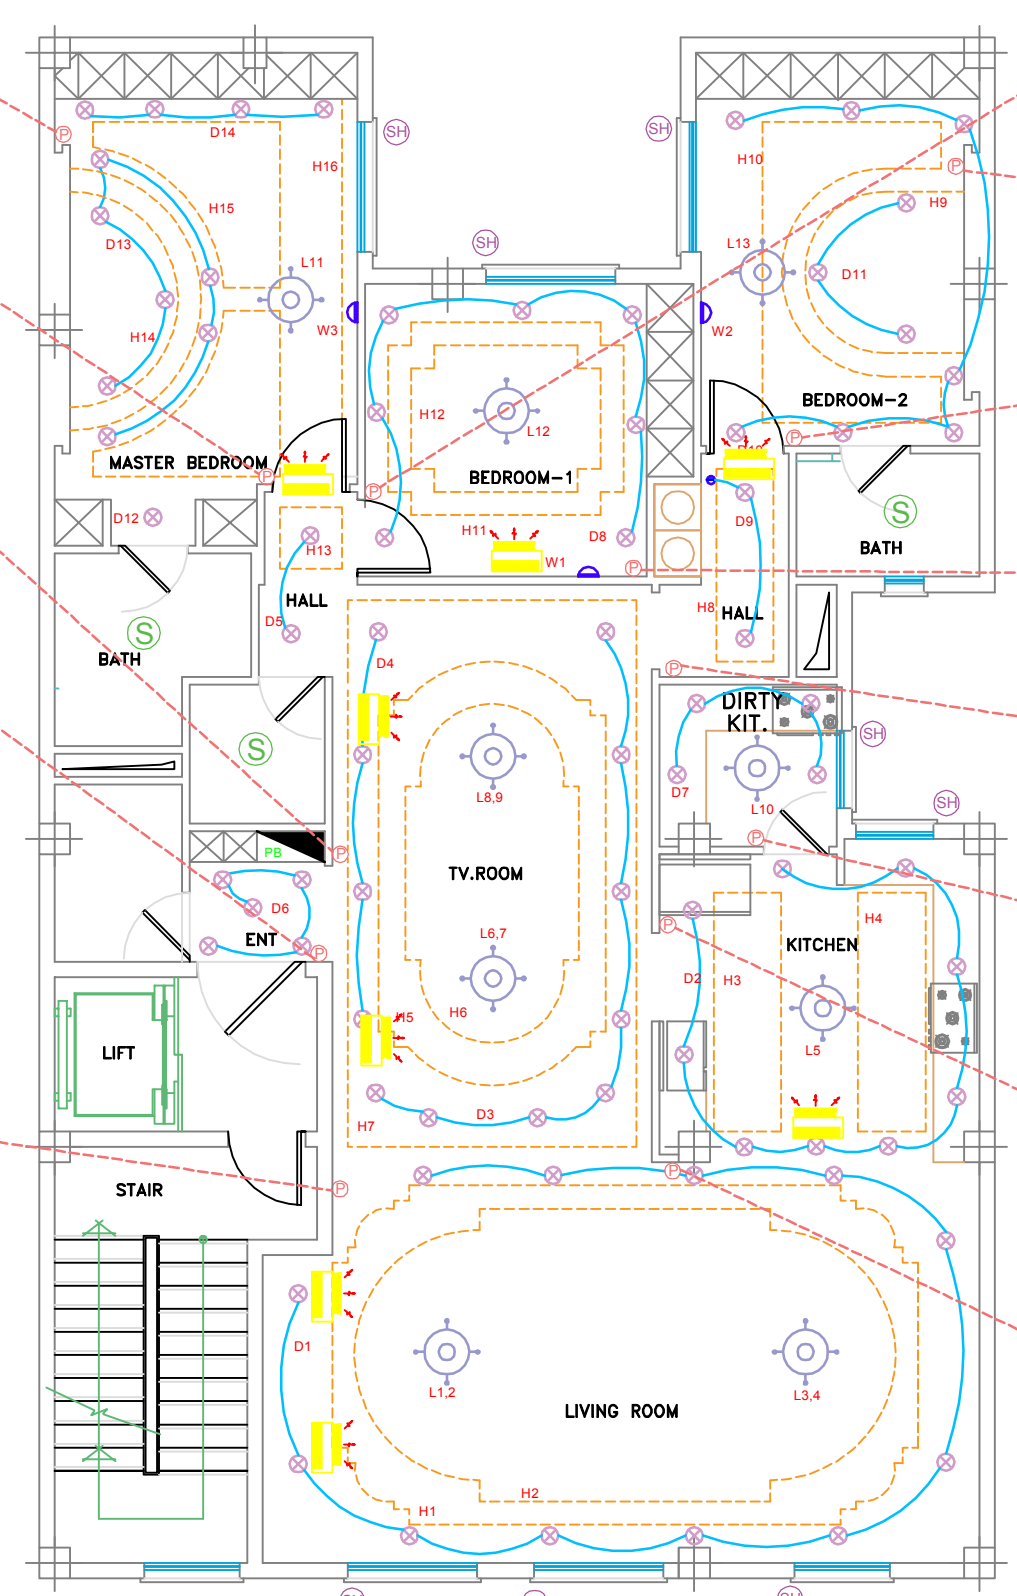

FLOOR PLAN

ABB-PREMIUM